


Order Plans @ WWW.DIline.com

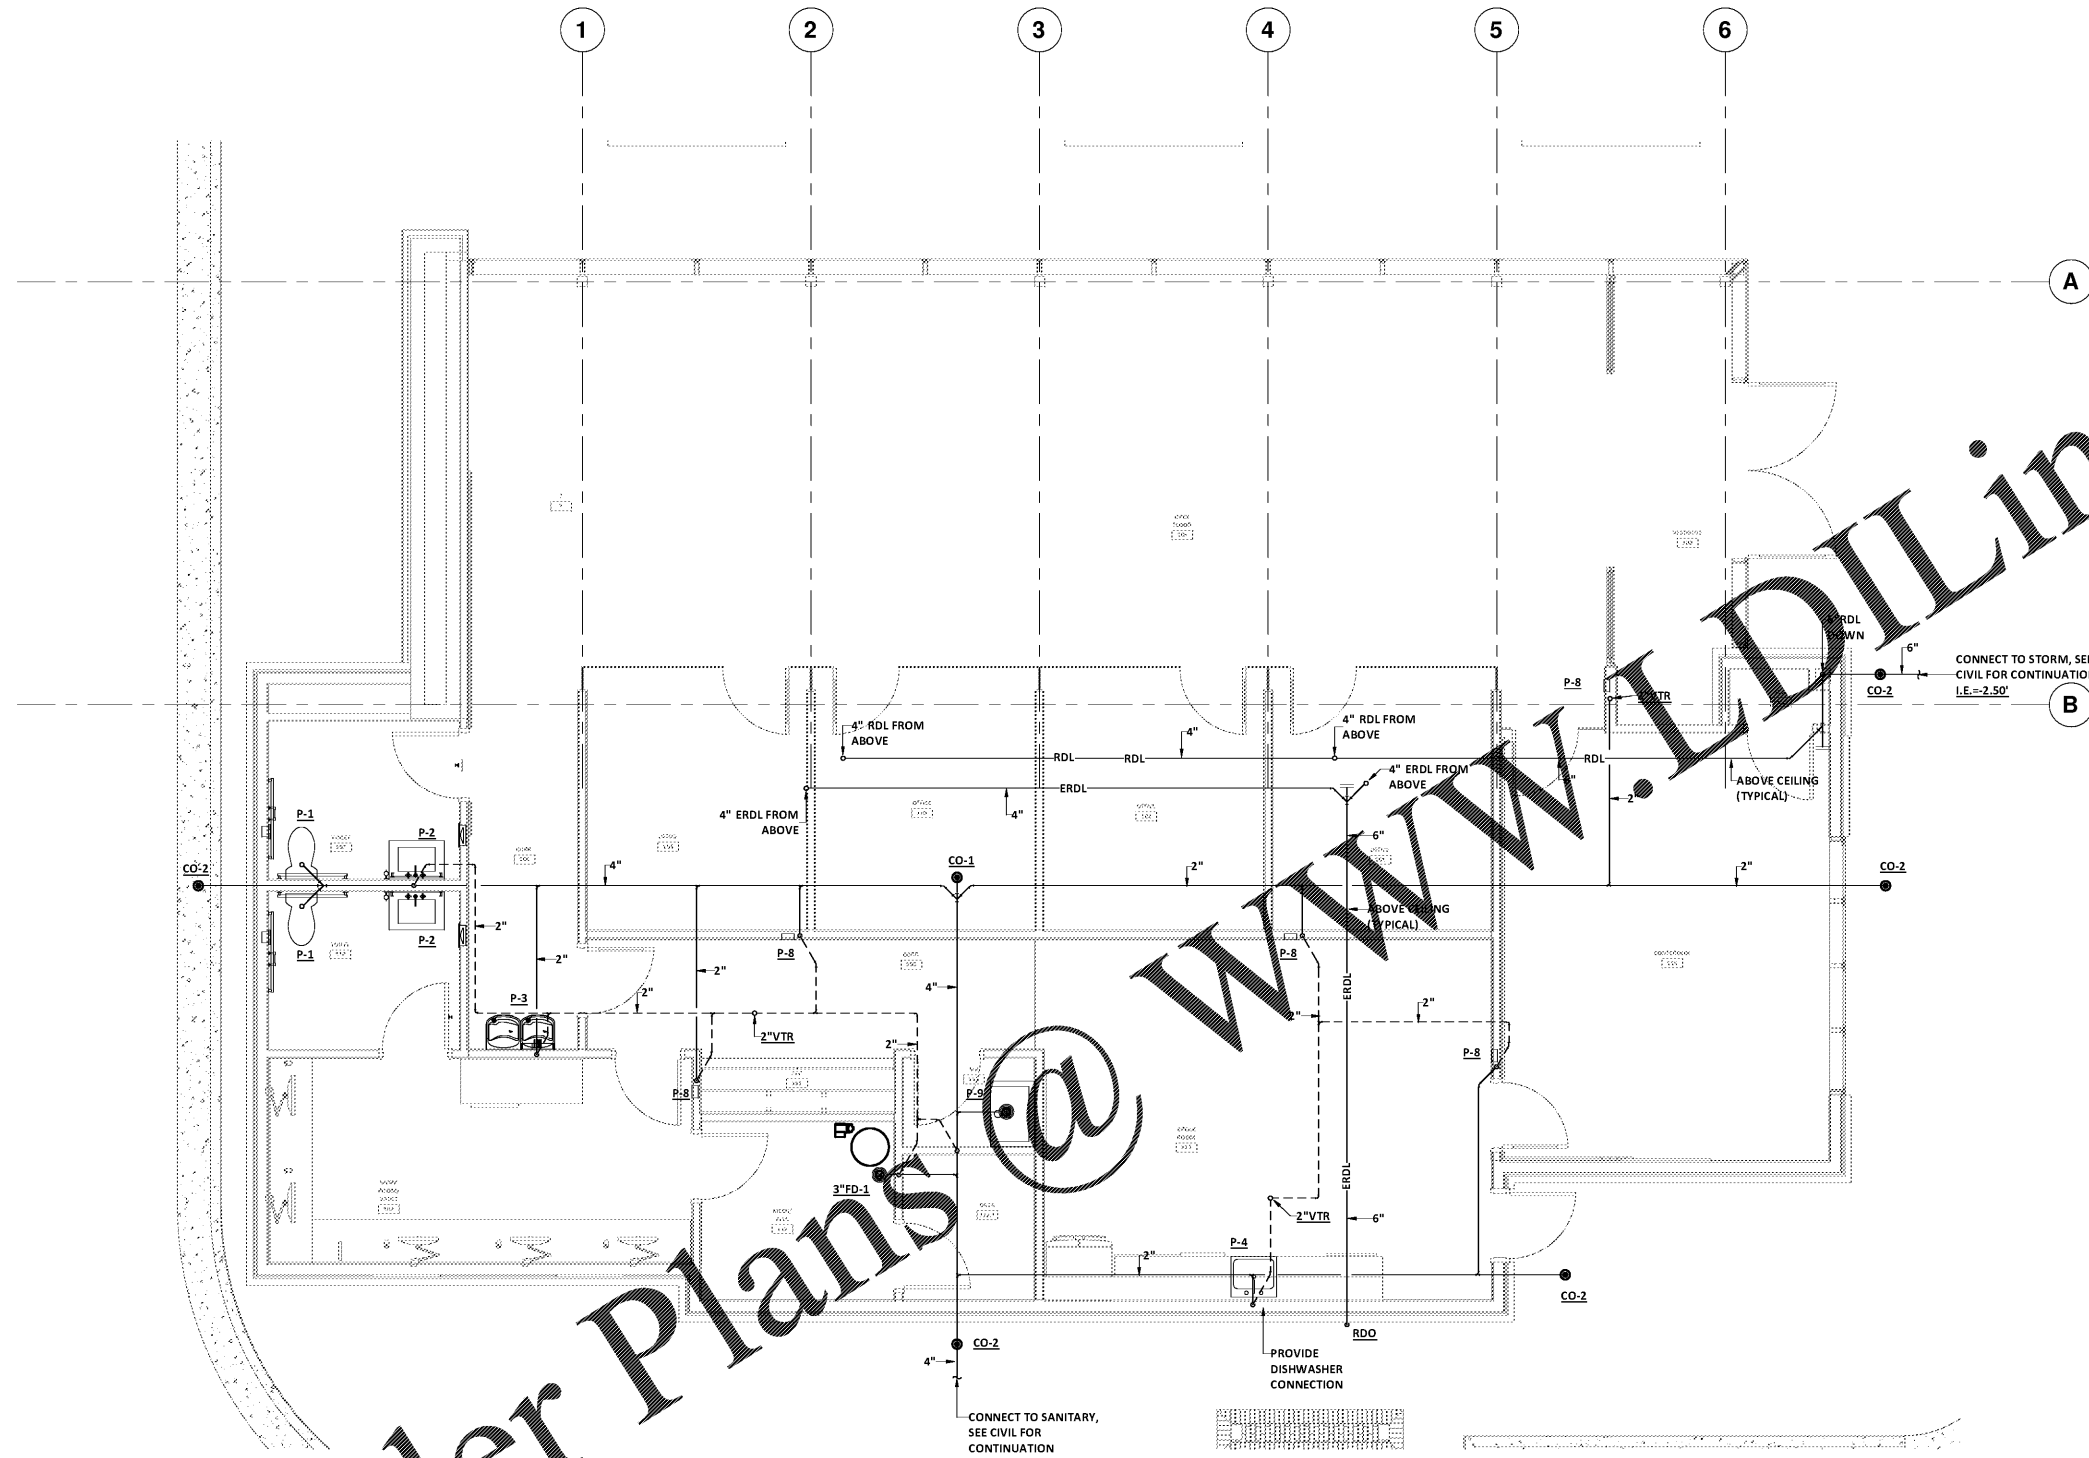

 
1 PLUMBING PLAN - WASTE AND VENT
 SCALE: 1/4" = 1'-0"



DA PROJECT NUMBER & NAME:
 2092
 DRAWING TITLE:
**PLUMBING PLAN
 WASTE AND VENT**

DRAWING NO:
P202

PFA
 PRUETT, FORD & ASSOCIATES, INC.
 ENGINEERS
 144 S.W. PEPPERBERRY DRIVE
 328 BROAD STREET, SUITE 304
 AUGUSTA, GEORGIA 30901
 706-722-7488 • FAX 706-722-8327
 WWW.PFA-ARCHITECTS.COM



PLOT DATE: 02/15/2021
 FILE NAME: 21003MECH
 PLOT SCALE: 1 = 48
 RWW

dickinson
 ARCHITECTS
 Architecture Interior Design Planning
 771 Broad Street Suite 200
 Augusta, Georgia 30901
 (706) 722-7488
 mail@dickinsonarchitects.com
 www.dickinsonarchitects.com

Member of the
 American Institute of
 Architects

THIS DRAWING IS THE PROPERTY OF DICKINSON ARCHITECTS, P.C., AND IS NOT TO BE REPRODUCED OR COPIED IN WHOLE OR IN PART OR USED FOR FURNISHING INFORMATION TO OTHERS OR FOR ANY OTHER PURPOSE DETRIMENTAL TO THE INTEREST OF DICKINSON ARCHITECTS, P.C., AND IS TO BE RETURNED UPON REQUEST.
 DICKINSON ARCHITECTS, P.C.

PROJECT TITLE:
**SRP
 BRANCH
 BANK**

REVISIONS			
REV #	DATE	APRVD BY	REVISION
1	03/17/21	JMF	Issue for Permit

COPYRIGHT © 2020
 PRUETT, FORD & ASSOCIATES, INC.
 AUGUSTA, GA 30901 (706) 722-8399