

dickinson
ARCHITECTS

Architecture|Interior Design|Planning
771 Broad Street Suite 200
Augusta, Georgia 30901
(706) 722-7488
mail@dickinsonarchitects.com
www.dickinsonarchitects.com



Member of the
American Institute of
Architects

THIS DRAWING IS THE PROPERTY OF DICKINSON ARCHITECTS, P.C., AND IS NOT TO BE REPRODUCED OR COPIED IN WHOLE OR IN PART OR USED FOR FURNISHING INFORMATION TO OTHERS, OR FOR ANY OTHER PURPOSE, WITHOUT THE WRITTEN CONSENT OF DICKINSON ARCHITECTS, P.C., AND IS TO BE RETURNED UPON REQUEST.
DICKINSON ARCHITECTS, P.C.

PROJECT TITLE:
**SRP
BRANCH
BANK**

REVISIONS

REV #	DATE	APRVD BY	REVISION
1	3/17/21	AF	ISSUE FOR PERMIT

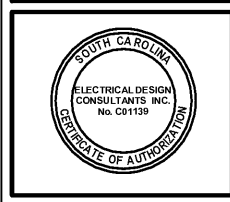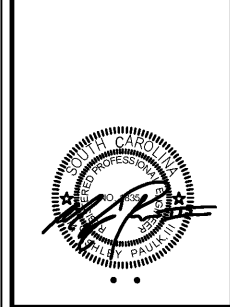

DA PROJECT NUMBER & NAME:
2092
DRAWING TITLE:
POWER PLAN


DRAWING NO:
E301

GENERAL NOTES

1. VERIFY MOUNTING HEIGHTS OF ALL ELECTRICAL OUTLETS WITH ARCHITECTURAL ELEVATIONS AND MILLWORK DRAWINGS PRIOR TO ROUGH IN.
2. ROUTE 1"Ø FROM ALL MILLWORK/FLOOR BOXES WHERE DATA DROPS ARE SHOWN TO ABOVE NEAREST ACCESSIBLE CEILING TO SERVE DATA CABLING.
3. COORDINATE HAND DRYER LOCATION WITH ARCHITECTURAL DRAWING PRIOR TO ROUGHING IN.
4. HOMERUN CIRCUITS ARE SHOWN AS NOTED. PROVIDE ALL BRANCH CIRCUIT CONDUIT/CONDUCTORS AS NECESSARY TO CONNECT ALL DEVICES SHOWN ON THE CIRCUIT. PROVIDE DEDICATED NEUTRALS FOR ALL CIRCUITS.
5. CONDUIT RUNS ARE SHOWN ON THESE TYPICAL PLANS AS UNDERGROUND ROUGH-IN. FOR ALL TYPICAL LAYOUTS ON SECOND FLOOR, ROUTE CONDUIT OVERHEAD. DO NOT ROUTE IN SLAB.
6. REFER TO ARCHITECTURAL PLANS FOR FLOOR BOX DIMENSIONS/LOCATIONS.

KEYED NOTES:

- 1 RECEPTACLE AND DATA DROP FOR EXTERIOR SIGNAGE. COORDINATE EXACT LOCATION WITH ARCHITECT.
- 2 MARK CIRCUIT BREAKER FOR FACP IN PANEL PER 2020 NEC. PROVIDE HASP LOCK.
- 3 OUTLETS FOR UNDERCOUNTER MICROWAVE. COORDINATE EXACT LOCATION WITH ARCHITECTURAL ELEVATIONS.
- 4 1/4"Ø FROM AV CABINET TO FLOORBOX.
- 5 (2)1-1/4"Ø FROM AV CABINET TO DATA OUTLET AT TV.
- 6 600VA SINGLE-PHASE CENTRAL LIGHTING INVERTER. BASIS OF DESIGN IS DUAL LITE LG600 SERIES.
- 7 LIGHTING CONTROL RELAY PANEL. SEE DETAIL 6/E702.
- 8 FOR SOUND MASKING SPEAKERS. COORDINATE EXACT LOCATION WITH ARCHITECT.

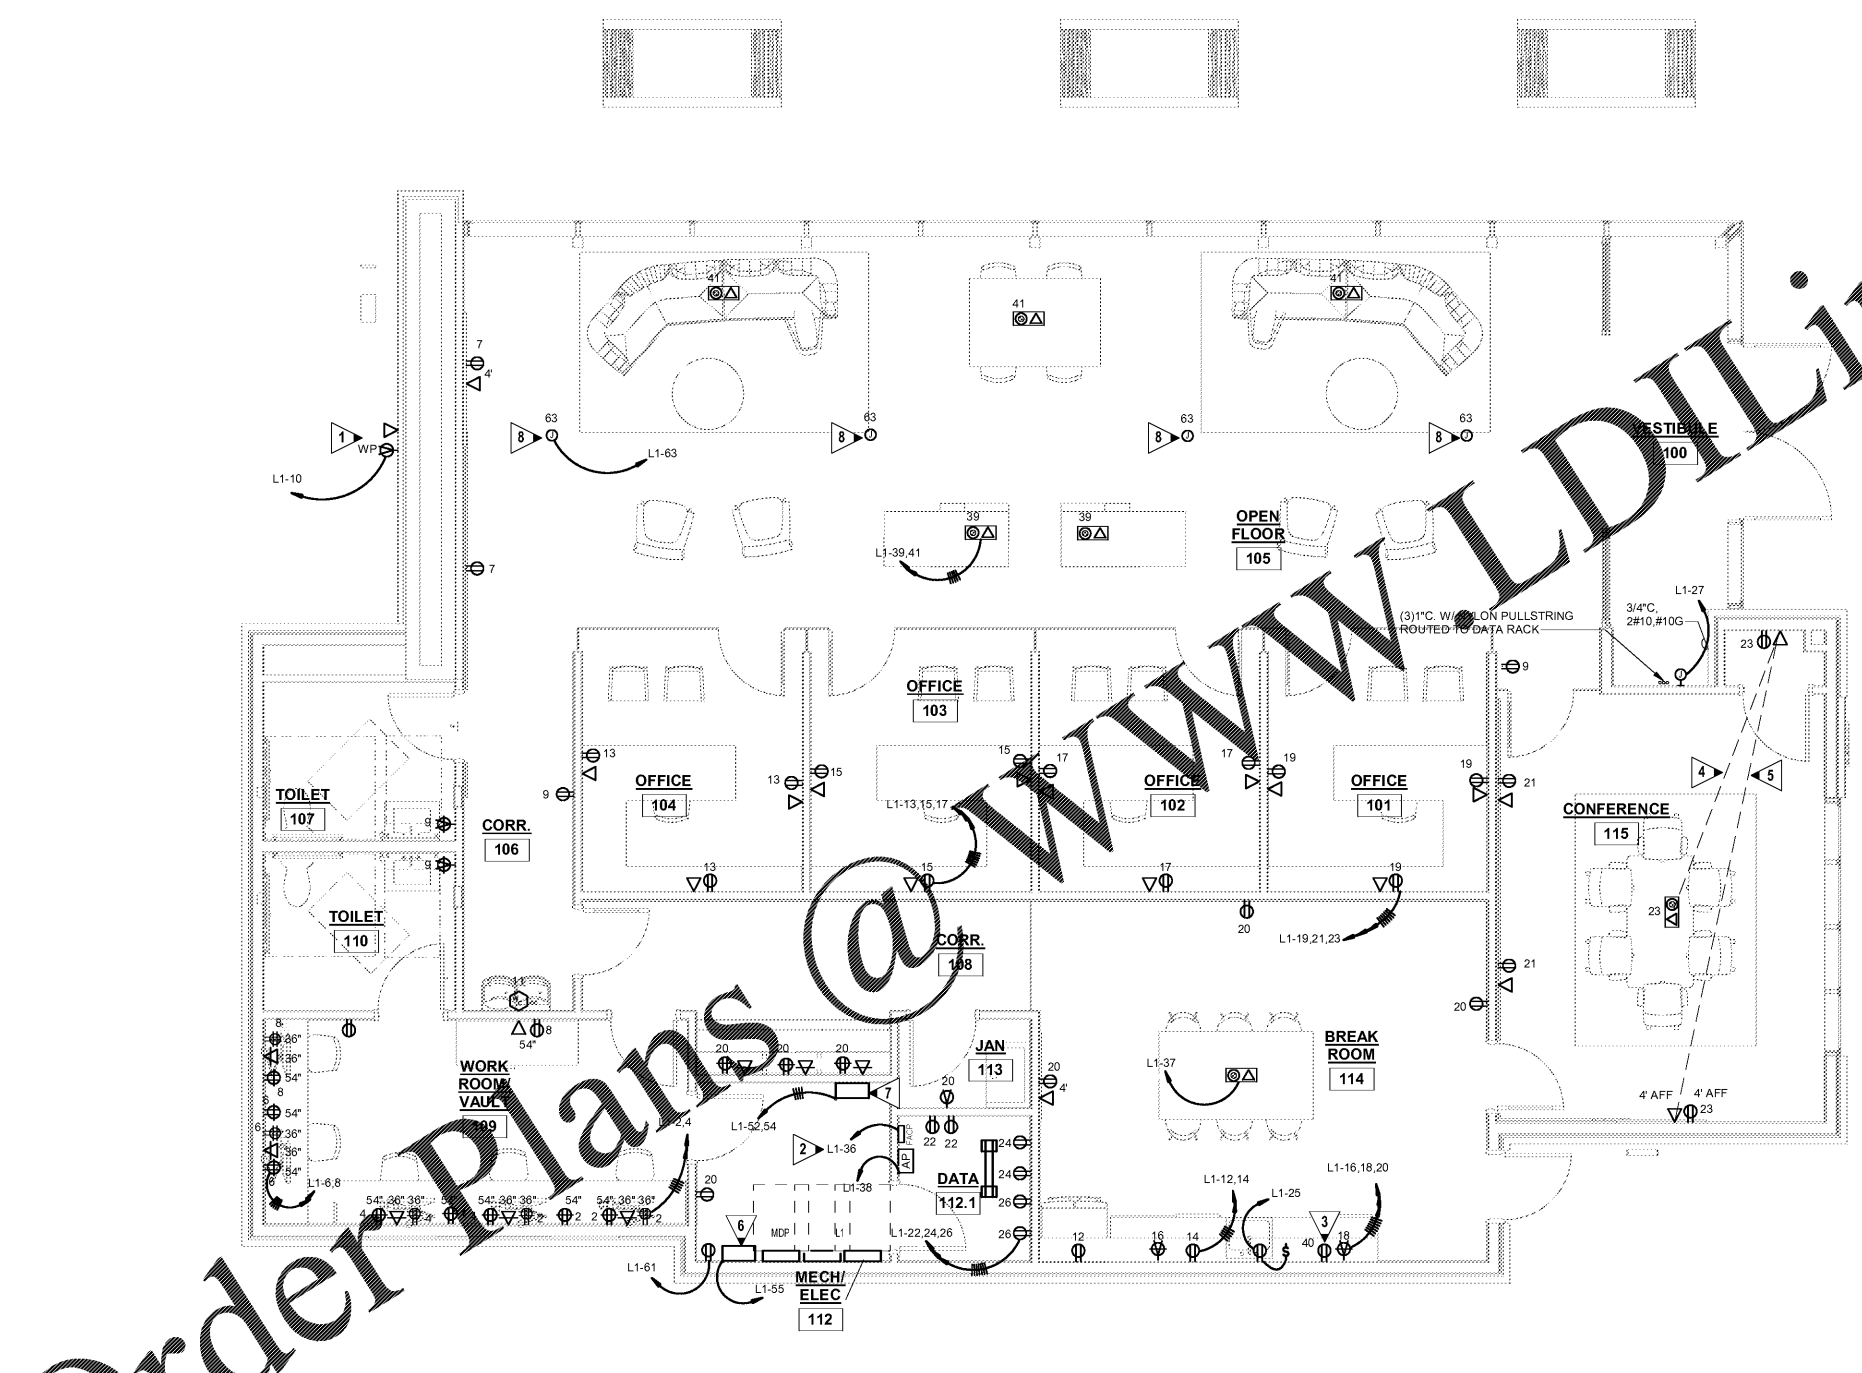

1 POWER PLAN
E301 SCALE: 1/4" = 1'-0"

Order Plans @ www.WLDLine.com

EDC ELECTRICAL DESIGN CONSULTANTS, INC.
ELECTRICAL ENGINEERS
1201 BROAD ST., SUITE 1-A
AUGUSTA, GA 30901
PH: (706) 724-3551
FAX: (706) 724-8597
EDC PROJECT # 21017