


Order Plans @ www.LDILine.com

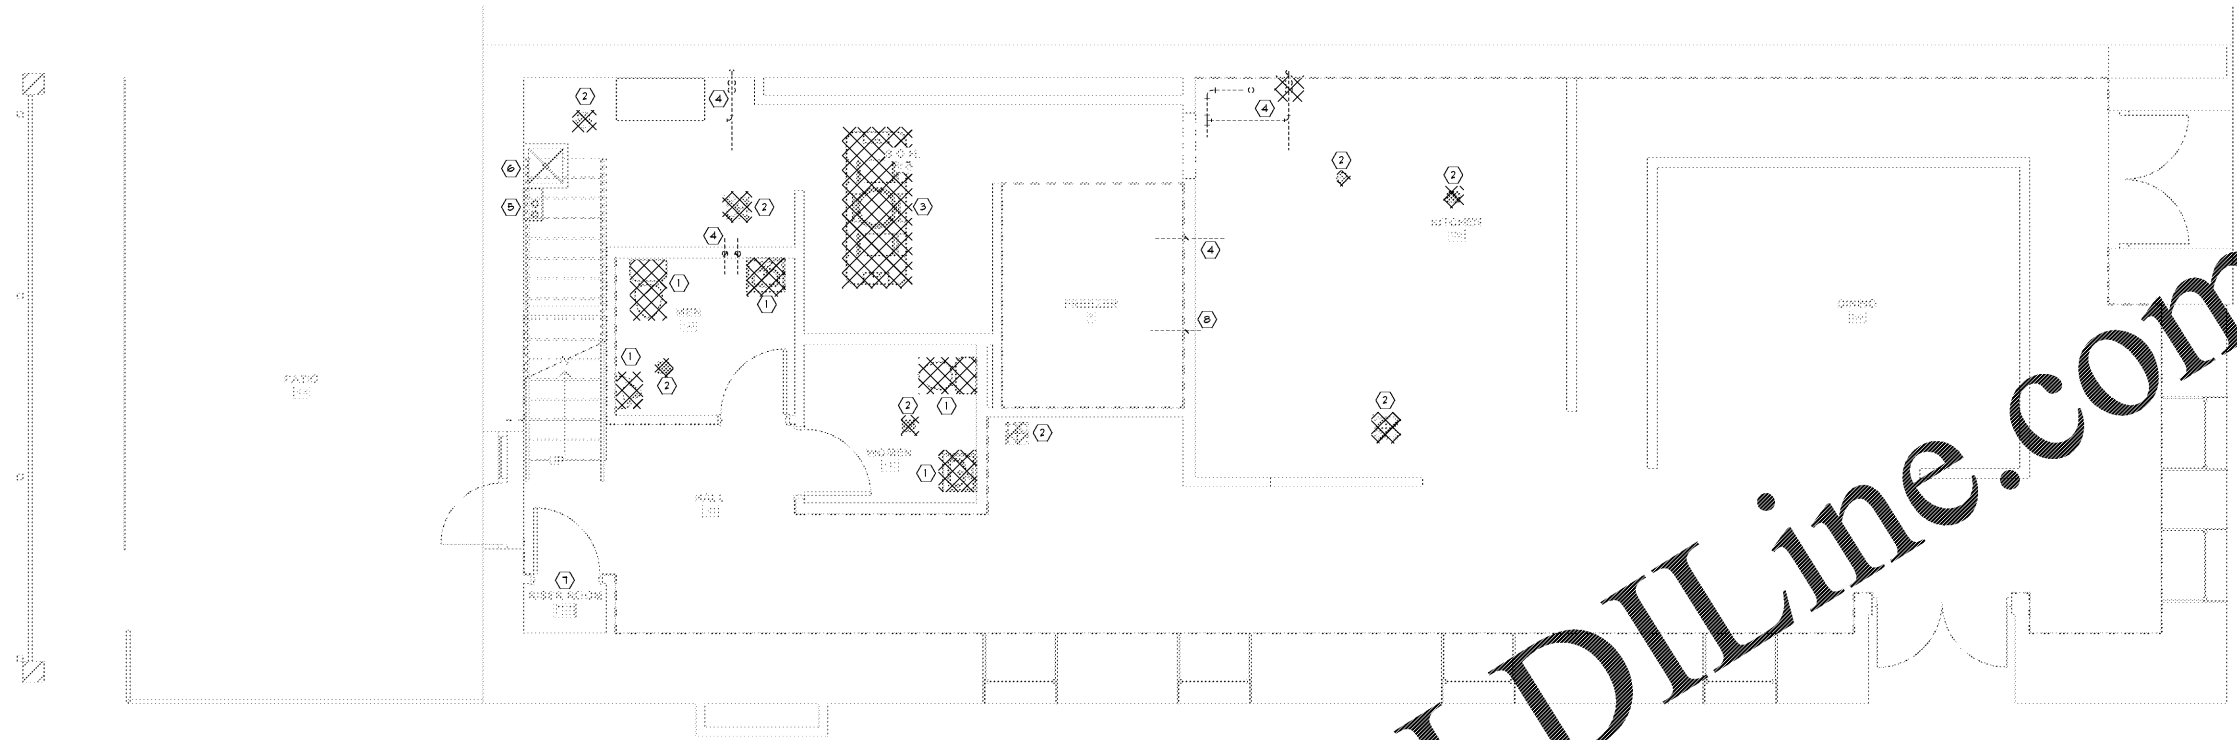

1ST FLOOR DEMOLITION PLAN - PLUMBING
 1/4" = 1'-0"
 NORTH

GENERAL NOTES:
 - SEE PG. 1 FOR PLUMBING LEGEND SYMBOLS AND ABBREVIATIONS.
 - DETAILS ARE APPLICABLE EXCEPT THEY ARE OTHERWISE REFERENCED.

- KEY NOTES:**
- ① REMOVE EXISTING SINK/FIXTURE, ASSOCIATED WATER AND SANITARY PIPING.
 - ② REMOVE EXISTING FLOOR DRAIN, SINK, AND/OR CLEANOUT.
 - ③ REMOVE EXISTING GREASE INTERCEPTOR BELOW EXISTING SLAB. COORDINATE WITH ARCHITECTURAL REQUIREMENTS FOR SLAB CUTTING AND PATCHING.
 - ④ REMOVE EXISTING PLUMBING ROUGH-IN INCLUDING SANITARY, VENT, AND DOMESTIC WATER PIPING.
 - ⑤ EXISTING WATER HEATER TO REMAIN AND BE REUSED.
 - ⑥ EXISTING MOP SERVICE SINK TO REMAIN AND BE REUSED.
 - ⑦ EXISTING FLOOR SINK TO REMAIN AND TIED INTO NEW SANITARY PIPING.
 - ⑧ REMOVE EXISTING GAS CONNECTION AND ASSOCIATED PIPING BACK TO GAS METER.




126 TICHENOR AVE
 AUBURN, AL 36830
 334.887.7010

IN ASSOCIATION WITH:



Mechanics • Electrical • Plumbing
 1100 South College Street
 Auburn, AL 36832
 P: (334) 829-8858 F: (334) 829-8899
 www.Conway-Owen.com

SEALS & SIGNATURES:

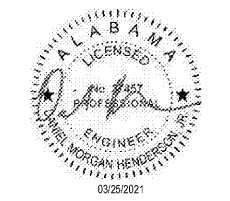

REV	DESCRIPTION	DATE

101 N COLLEGE STREET

101 N. COLLEGE STREET
 AUBURN, AL 36830



Project No.: SNA Project #: 2021-04
 Client Project No.: 210000X

Drawing Title:
**FIRST FLOOR DEMOLITION
 PLAN - PLUMBING**

Date: 03/25/2021 Phase:
 Designed: Designer Drawing No.:
 Drawn: Author
 Checked: Checker **P1.0**