




126 TICHENOR AVE
AUBURN, AL 36830
334.887.7010


IN ASSOCIATION WITH:



SEALS & SIGNATURES:

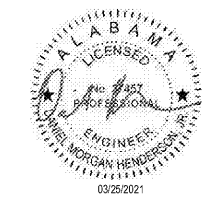

REV	DESCRIPTION	DATE

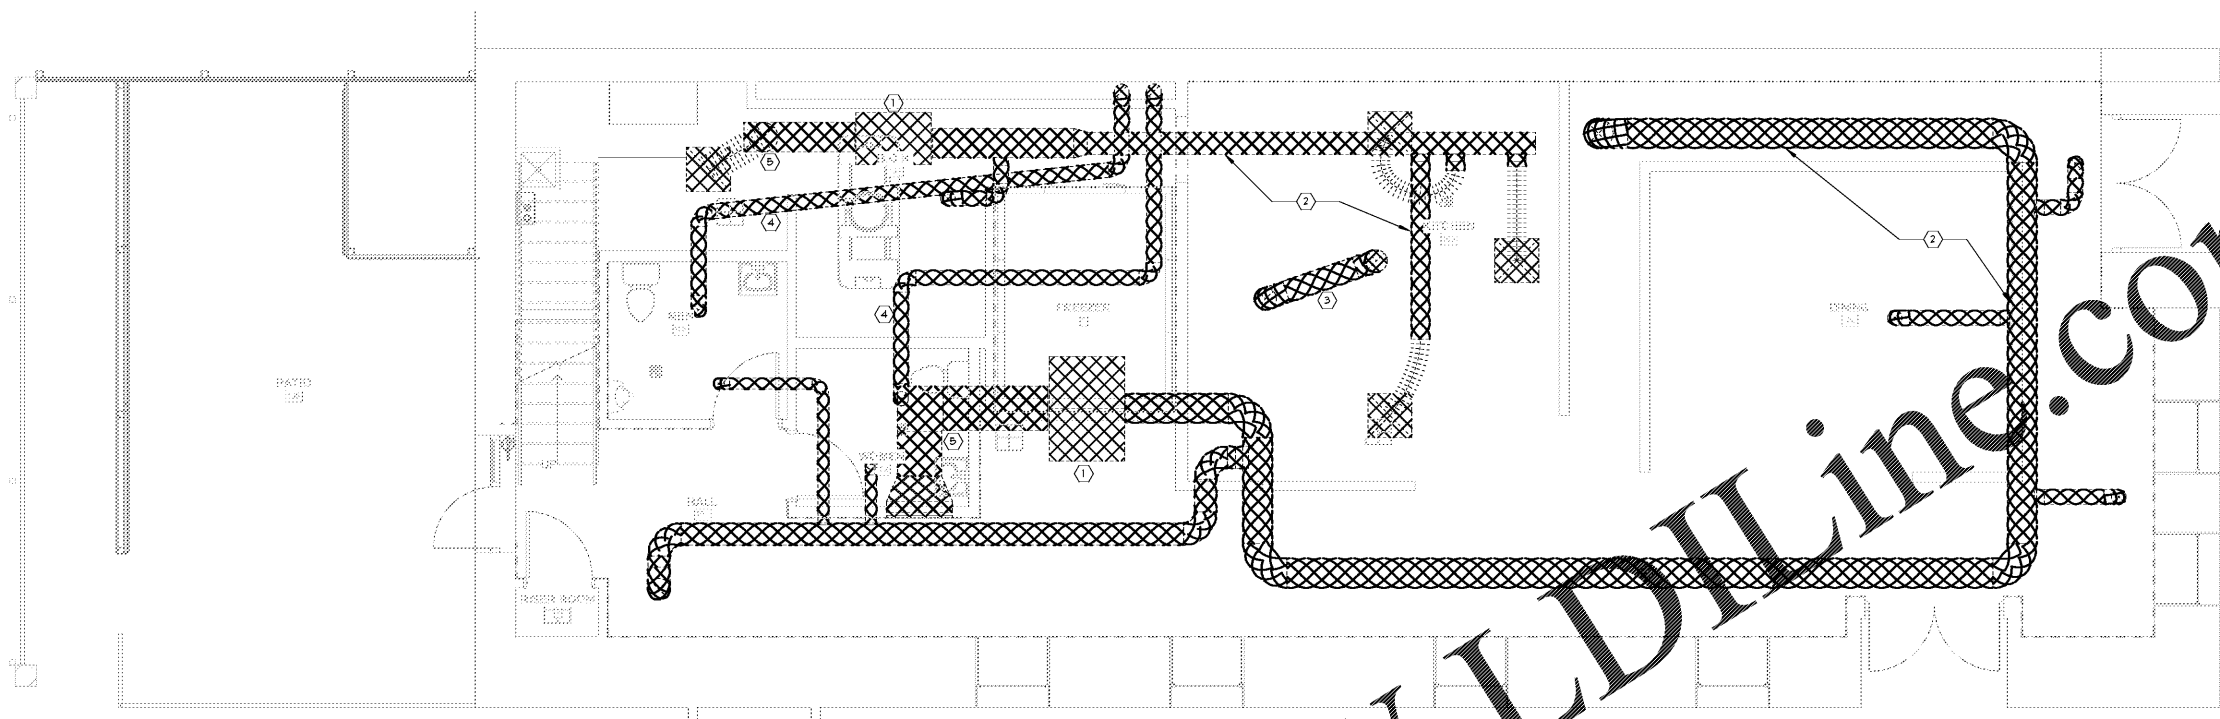

1 1ST FLOOR DEMOLITION PLAN - HVAC
1/4" = 1'-0"

GENERAL NOTES:
- SEE 'M' FOR MECHANICAL LEGEND, SYMBOLS & ASSOCIATIONS
- DETAILS ARE APPLICABLE EVEN IF THEY ARE NOT DIRECTLY REFERENCED.

ITEMS UNDER HATCHING TO BE DEMOLISHED

- KEY NOTES:**
- ① REMOVE EXISTING AIR HANDLING UNIT, ASSOCIATED DUCTWORK, PIPING, POWER AND CONTROLS.
 - ② REMOVE EXISTING DUCTWORK AND ASSOCIATED DIFFUSERS.
 - ③ REMOVE EXISTING GREASE DUCT AND ASSOCIATED FAN.
 - ④ REMOVE EXISTING EXHAUST DUCT AND ASSOCIATED FAN.
 - ⑤ REMOVE RETURN AIR DUCT AND ASSOCIATED DIFFUSERS.

Order Plans @ www.LDILine.com

101 N COLLEGE STREET
101 N. COLLEGE STREET
AUBURN, AL 36830



Project No.: SNA Project # 2021-04
Client Project No.: 210000X
Drawing Title:
**FIRST FLOOR DEMOLITION
PLAN - HVAC**
Date: 03/25/2021 Phase:
Designed: Designer Drawing No.:
Drawn: Author
Checked: Checker **M1.0**