




126 TICHENOR AVE
AUBURN, AL 36830
334.887.7010

IN ASSOCIATION WITH:



Mechanics • Electrical • Plumbing
1100 South College Street
Auburn, AL 36832
P: (334) 829-8858 F: (334) 829-8859
www.Conway-Owen.com


SEALS & SIGNATURES:

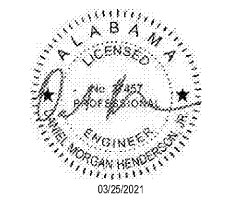

REV	DESCRIPTION	DATE

Order Plans @

WWW.LDILINE.COM

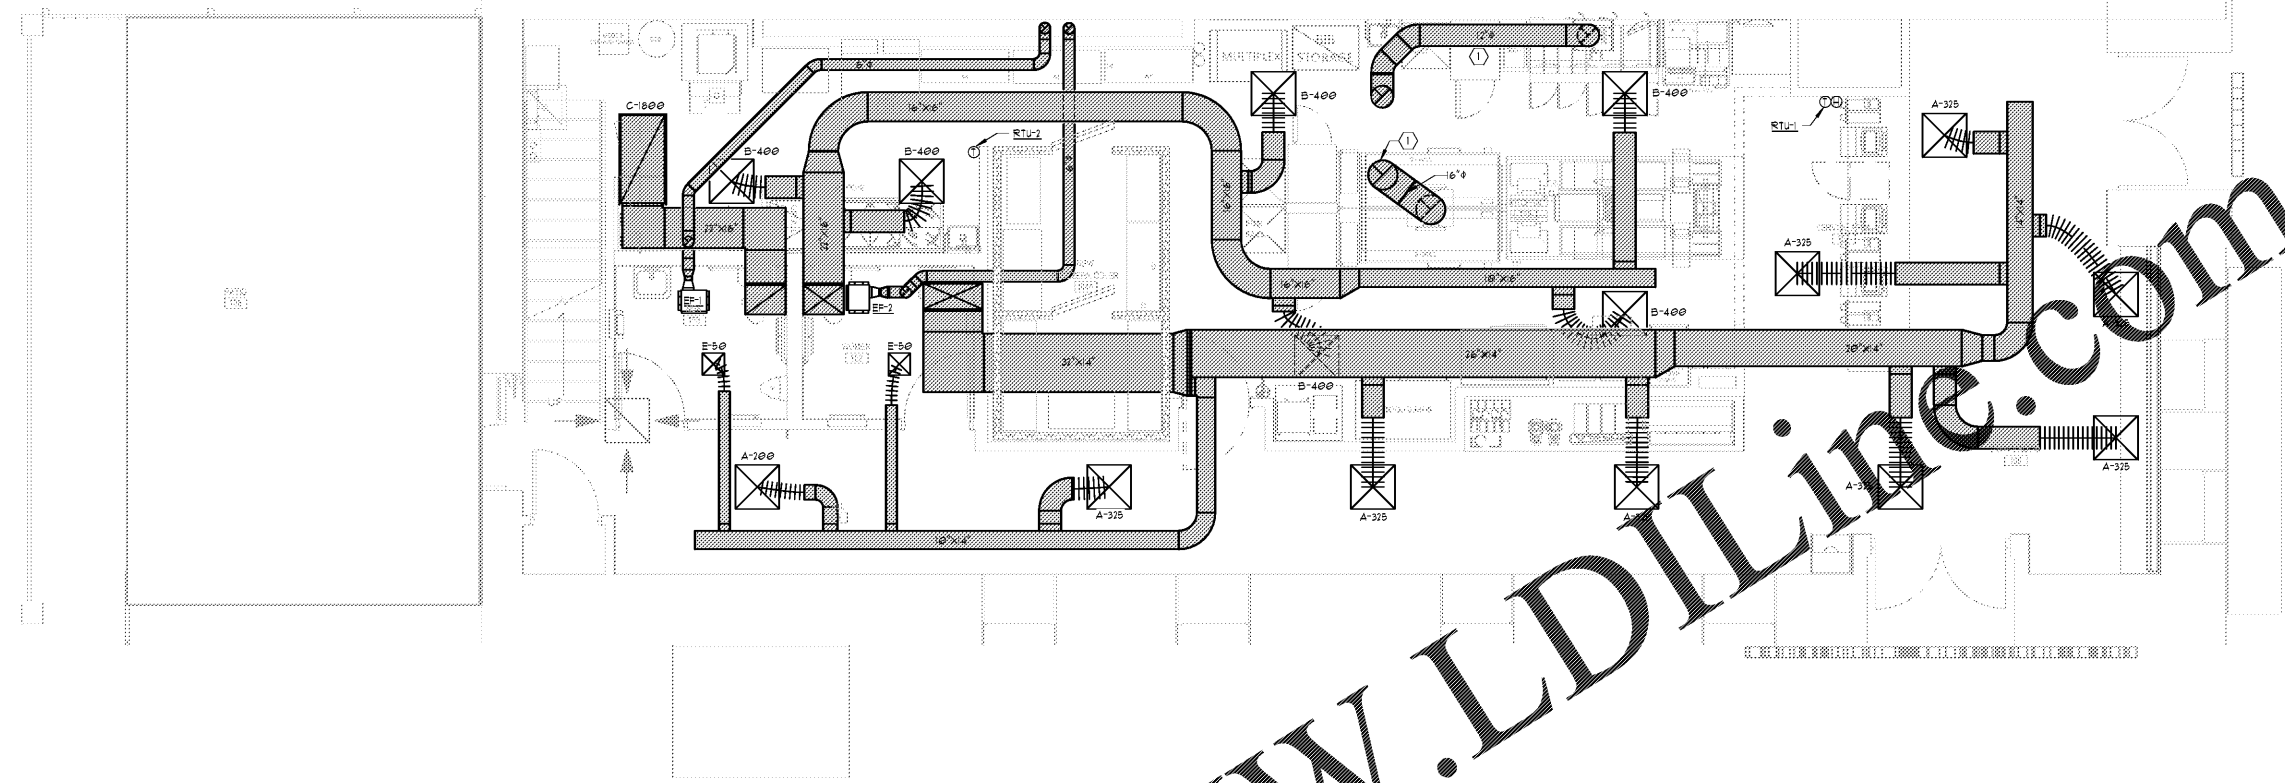

1ST FLOOR PLAN - HVAC
1/4" = 1'-0"

GENERAL NOTES:
SEE MOP FOR MECHANICAL LEGEND, SYMBOLS, & ABBREVIATIONS.
DETAILS ARE APPLICABLE EVEN IF THEY ARE NOT DIRECTLY REFERENCED.

KEY NOTES:
① GREASE DUCT ROUTED UP TO EXHAUST FAN ON ROOF. GREASE DUCT SHALL BE WRAPPED WITH FIRE RATED DUCT WRAP UP TO ROOF.

101 N COLLEGE STREET
101 N. COLLEGE STREET
AUBURN, AL 36830



Project No.: SNA Project #: 2021-04
Client Project No.: 210000X

Drawing Title:
FIRST FLOOR PLAN - HVAC

Date: 03/25/2021 Phase:
Designed: Designer Drawing No.:
Drawn: Author
Checked: Checker **M2.0**