




126 TICHENOR AVE
AUBURN, AL 36830
334.887.7010

IN ASSOCIATION WITH:



Mechanics • Electrical • Plumbing
1100 South College Street
Auburn, AL 36832
P: (334) 829-8858 F: (334) 829-8859
www.Conway-Owen.com

SEALS & SIGNATURES:

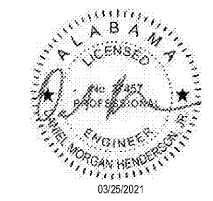

REV	DESCRIPTION	DATE

101 N COLLEGE STREET


101 N. COLLEGE STREET
AUBURN, AL 36830



Project No.: SNA Project # 2021-04
Client Project No.: 210000X

Drawing Title:
ROOF PLAN - HVAC

Date: 03/25/2021	Phase:
Designed: Designer	Drawing No.:
Drawn: Author	M2.2
Checked: Checker	

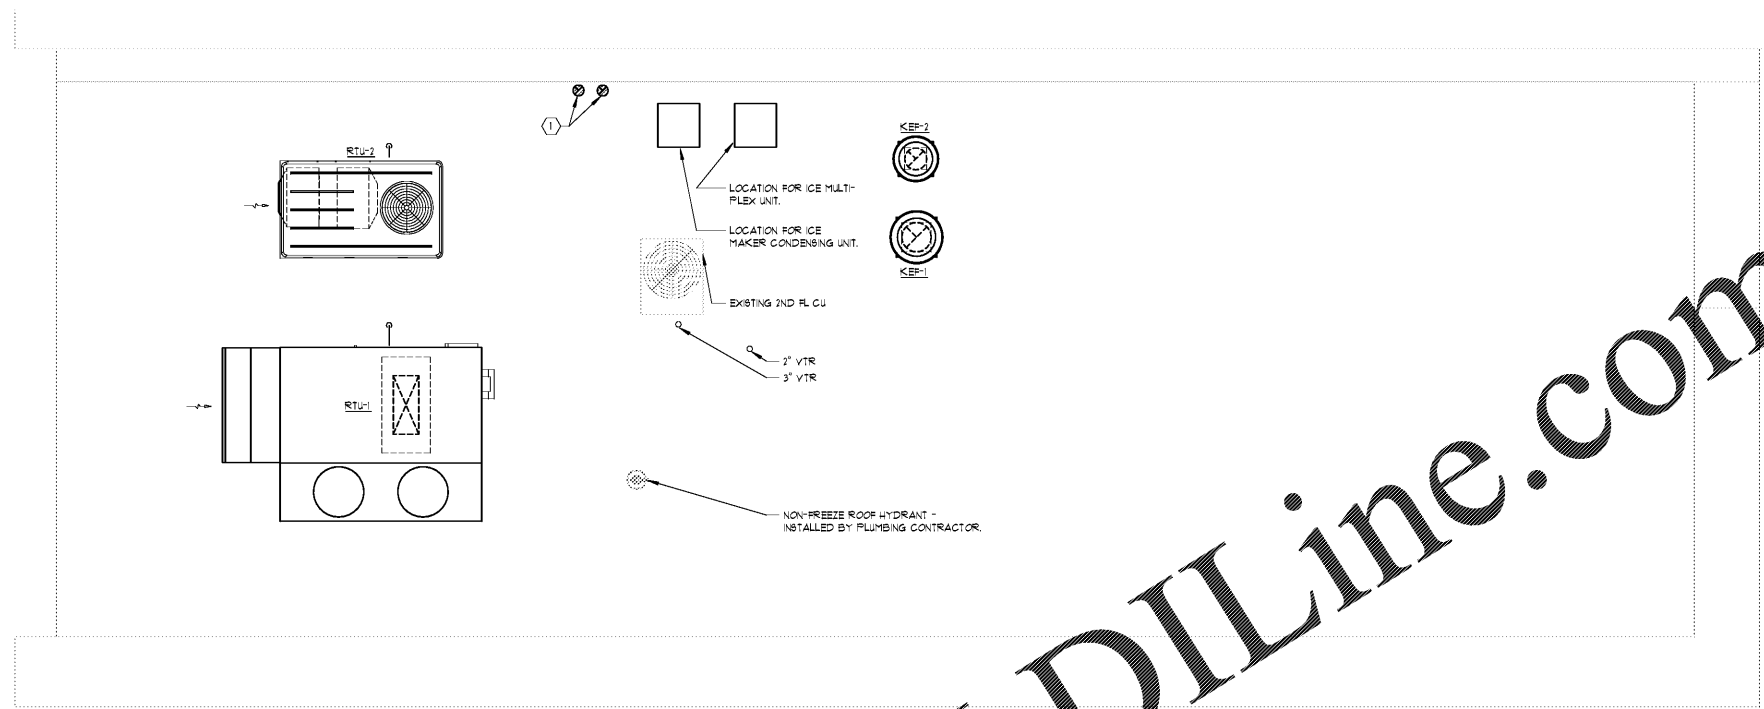

ROOF PLAN - HVAC
1/4" = 1'-0"
NORTH

GENERAL NOTES
SEE MECHANICAL SCHEDULES FOR SYMBOLS & ABBREVIATIONS.
DETAILS ARE APPLICABLE UNLESS THEY ARE NOT DIRECTLY REFERENCED.

KEY NOTES
1. TERMINATE EXHAUST DUCT WITH ROOF CAP.

Order Plans @ www.LDILine.com