

◊ = KITCHEN EQUIPMENT KEYNOTE, SEE KITCHEN EQUIPMENT SCHEDULE, SHEET E02 FOR ADDITIONAL INFORMATION

ELECTRICAL GENERAL NOTES: (APPLY TO THIS SHEET ONLY)

- COORDINATE EXACT LOCATION FOR ALL ELECTRICAL AND LIGHTING DEVICES WITH ARCHITECT PRIOR TO INSTALLATION
- LABEL PANELBOARD SCHEDULES PER NEC 408.4

ELECTRICAL KEY NOTES: (APPLY TO THIS SHEET ONLY)

- ① UNIT PROVIDED WITH INTEGRAL WEATHERPROOF GFCI MAINTENANCE RECEPTACLE




126 TICHENOR AVE
AUBURN, AL 36830
334.887.7010

IN ASSOCIATION WITH:




Mechanics • Electrical • Plumbing
1100 South College Street
Auburn, AL 36832
P: (334) 829-8858 F: (334) 829-8899
www.Conway-Owen.com

SEALS & SIGNATURES:

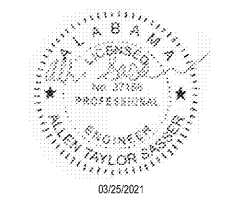

REV	DESCRIPTION	DATE

Order Plans @ www.LDILine.com

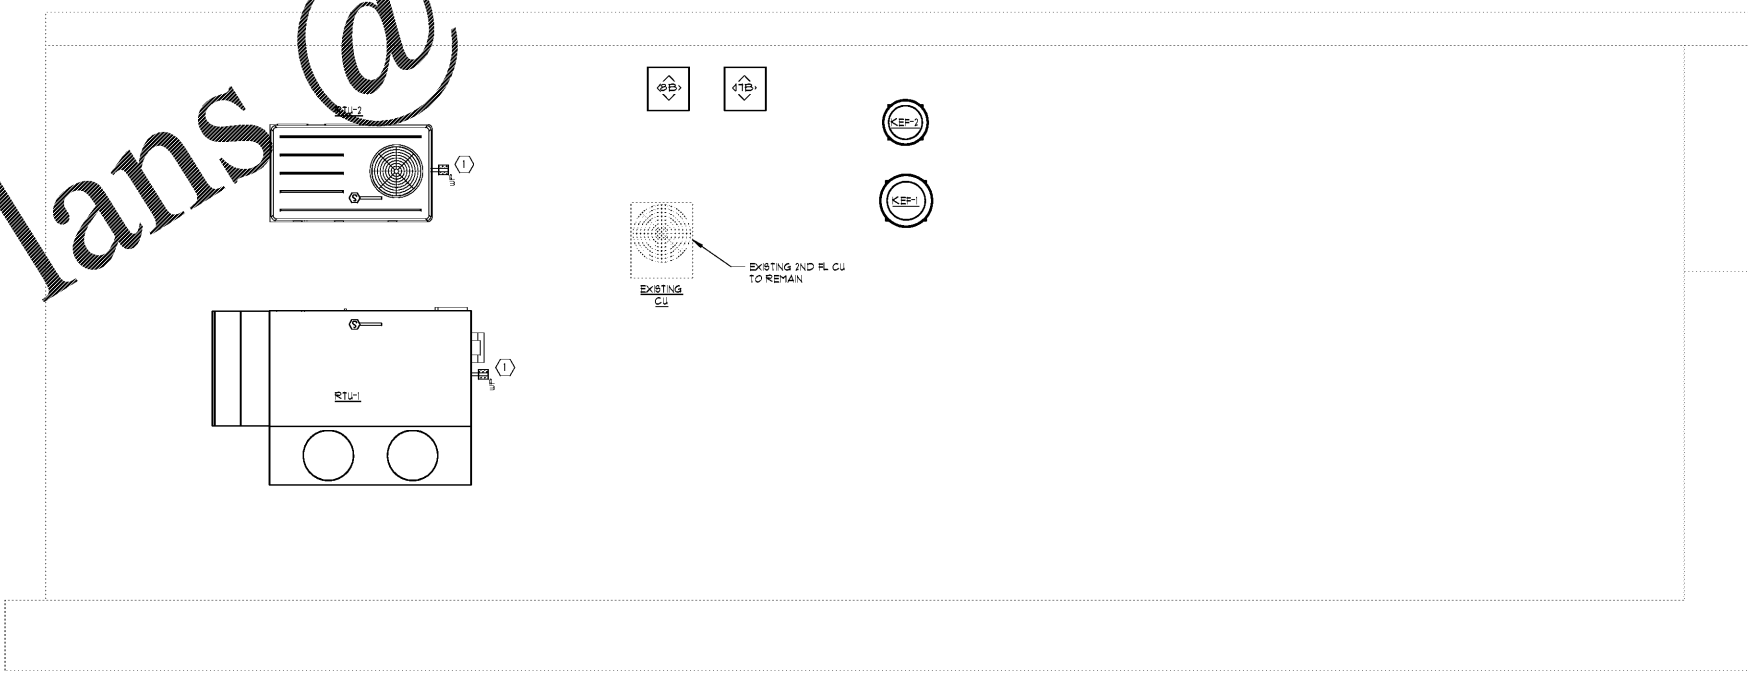

ROOF PLAN - ELECTRICAL
1/4" = 1'-0"
NORTH

101 N COLLEGE STREET

101 N. COLLEGE STREET
AUBURN, AL 36830



Project No.: SNA Project #: 2021-04
Client Project No.: 210000X

Drawing Title:
ROOF PLAN - ELECTRICAL

Date: 03/25/2021 Phase:
Designed: ---
Drawn: ---
Checked: ---
Drawing No.:
E1.4