


Order Plans @ WWW.I.D.I.Line.com

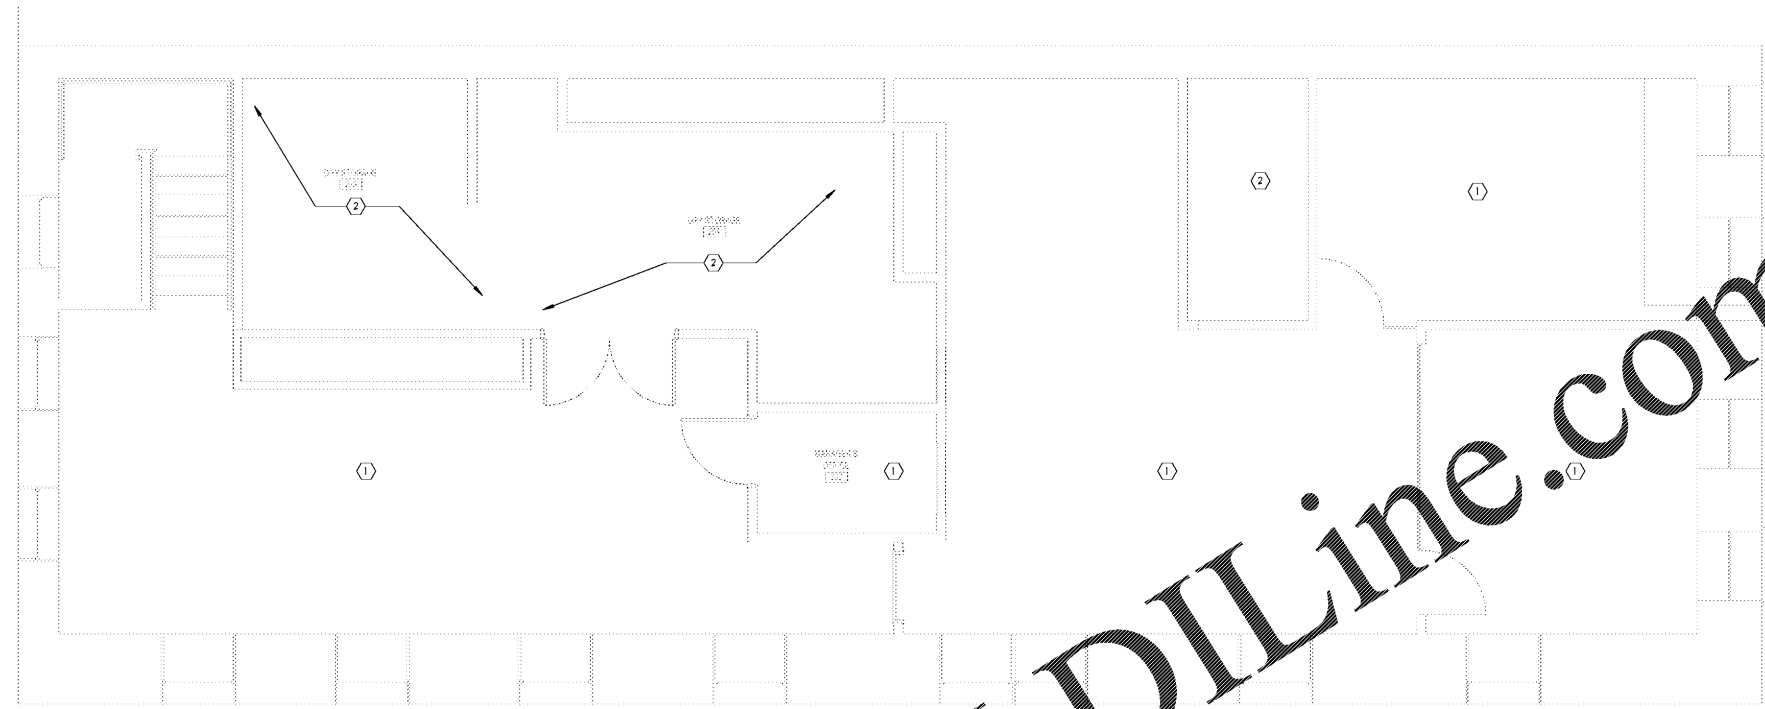

2ND FLOOR PLAN - FIRE PROTECTION
1/4" = 1'-0"

GENERAL NOTES:
 1. COPY, REMOVE OR ADD TO EXISTING FIRE SPRINKLER SYSTEM SO THAT IT COMPLIES WITH NFPA 13.
 2. REMOVE AND REPLACE EXISTING SPRINKLER HEADS AS NEEDED TO COMPLY WITH NFPA 13.

KEY NOTES:
 1. LIGHT HAZARD CLASSIFICATION
 2. ORDINARY HAZARD, GROUP 1 CLASSIFICATION



126 TICHENOR AVE
AUBURN, AL 36830
334.887.7010

IN ASSOCIATION WITH:



Mechanics • Electrical • Plumbing
 1100 South College Street
 Auburn, AL 36832
 P: (334) 829-8858 F: (334) 829-8899
www.Conway-Owen.com

SEALS & SIGNATURES:



REV	DESCRIPTION	DATE

101 N COLLEGE STREET

101 N. COLLEGE STREET
AUBURN, AL 36830



Project No.: SNA Project #: 2021-04
 Client Project No.: 210000X

Drawing Title:
SECOND FLOOR PLAN - FIRE PROTECTION

Date: 03/25/2021 Phase:
 Designed: DMH Drawing No.:
 Drawn: DMH
 Checked: DMH

F2.1