



DRAWING ISSUE RECORD		
DATE	REVISIONS	NO.
4-8-2021	ISSUE TO BID	

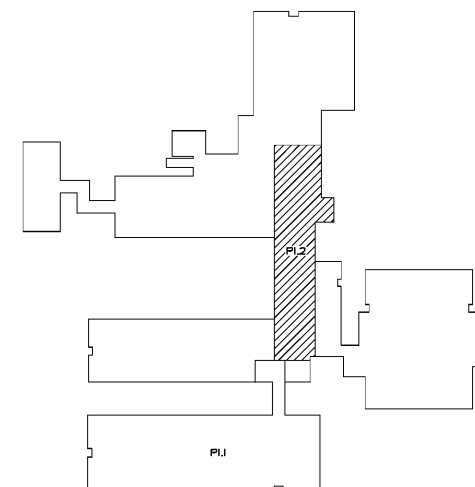

KEY PLAN

1 FLOOR PLAN - PLUMBING
P1.1 1/8"=1'-0"

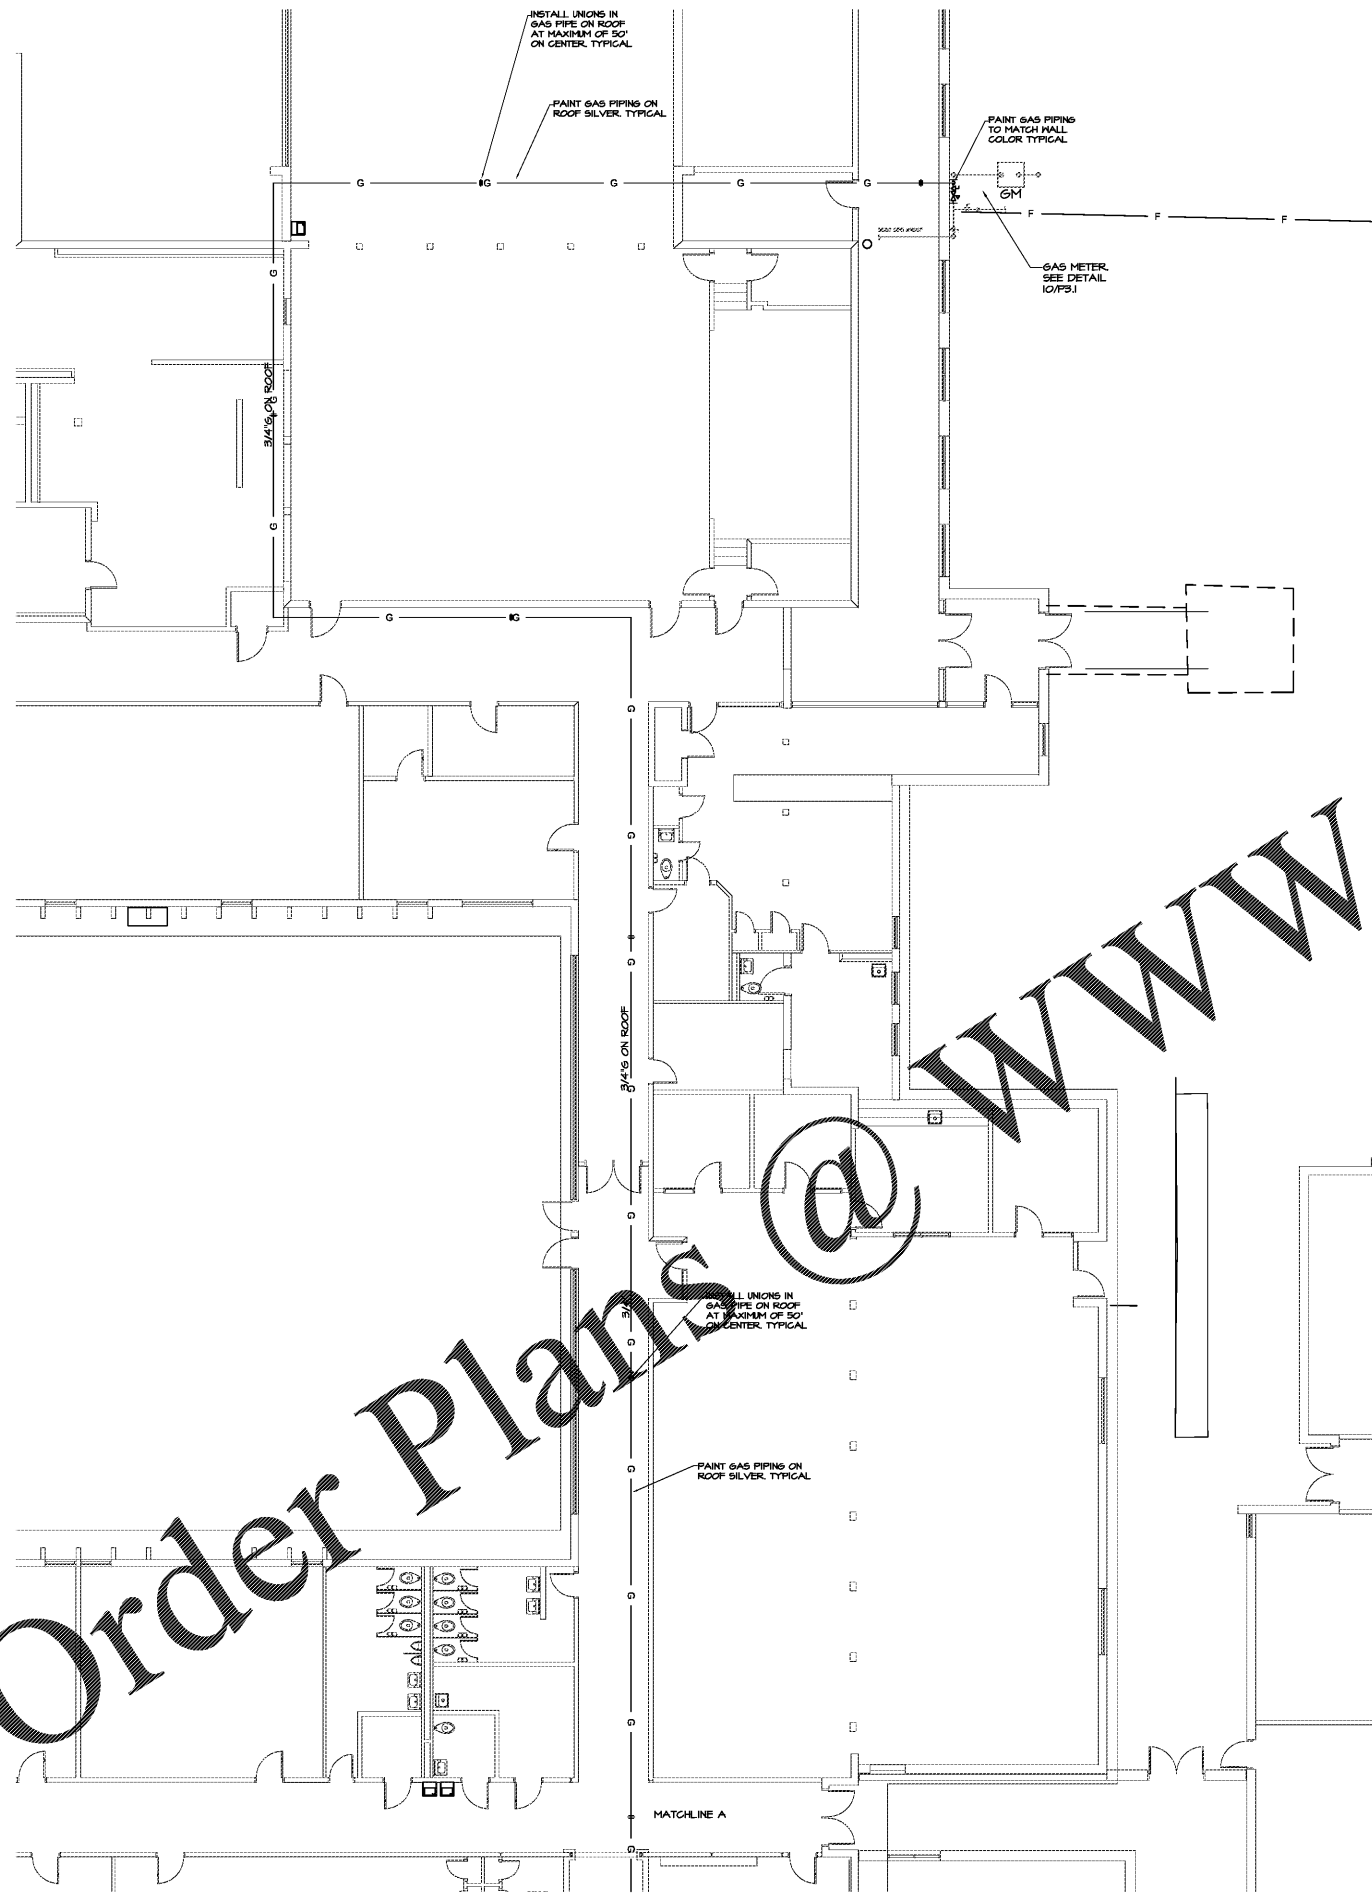

SPURLOCK & ASSOCIATES, INC.
consulting engineers
2970 Clairmont Rd., Suite 620 | Atlanta, GA 30329
P: 404.632.0245 | F: 404.632.1736
GA JOB NO. 2103

cunningham forehand matthews moore

cunningham, forehand, matthews & moore, architects, inc. - 2011 manchester street, n.e. - atlanta, georgia 30324 - phone (404) 873-2152

ADDITION TO COLHAM FERRY
ELEMENTARY SCHOOL
191 COLHAM FERRY ROAD, MARIETTA, GA 30067
FOR THE BOARD OF EDUCATION
OCONEE COUNTY, GA
DDE FACILITY CODE 3530

DATE: DECEMBER 15, 2021
JOB NO. B-L-2021-20
DWG. BY: J.C.F.
CHK. BY: M.W.D.

Order Plans @ www.LDILine.com