


Order Plans

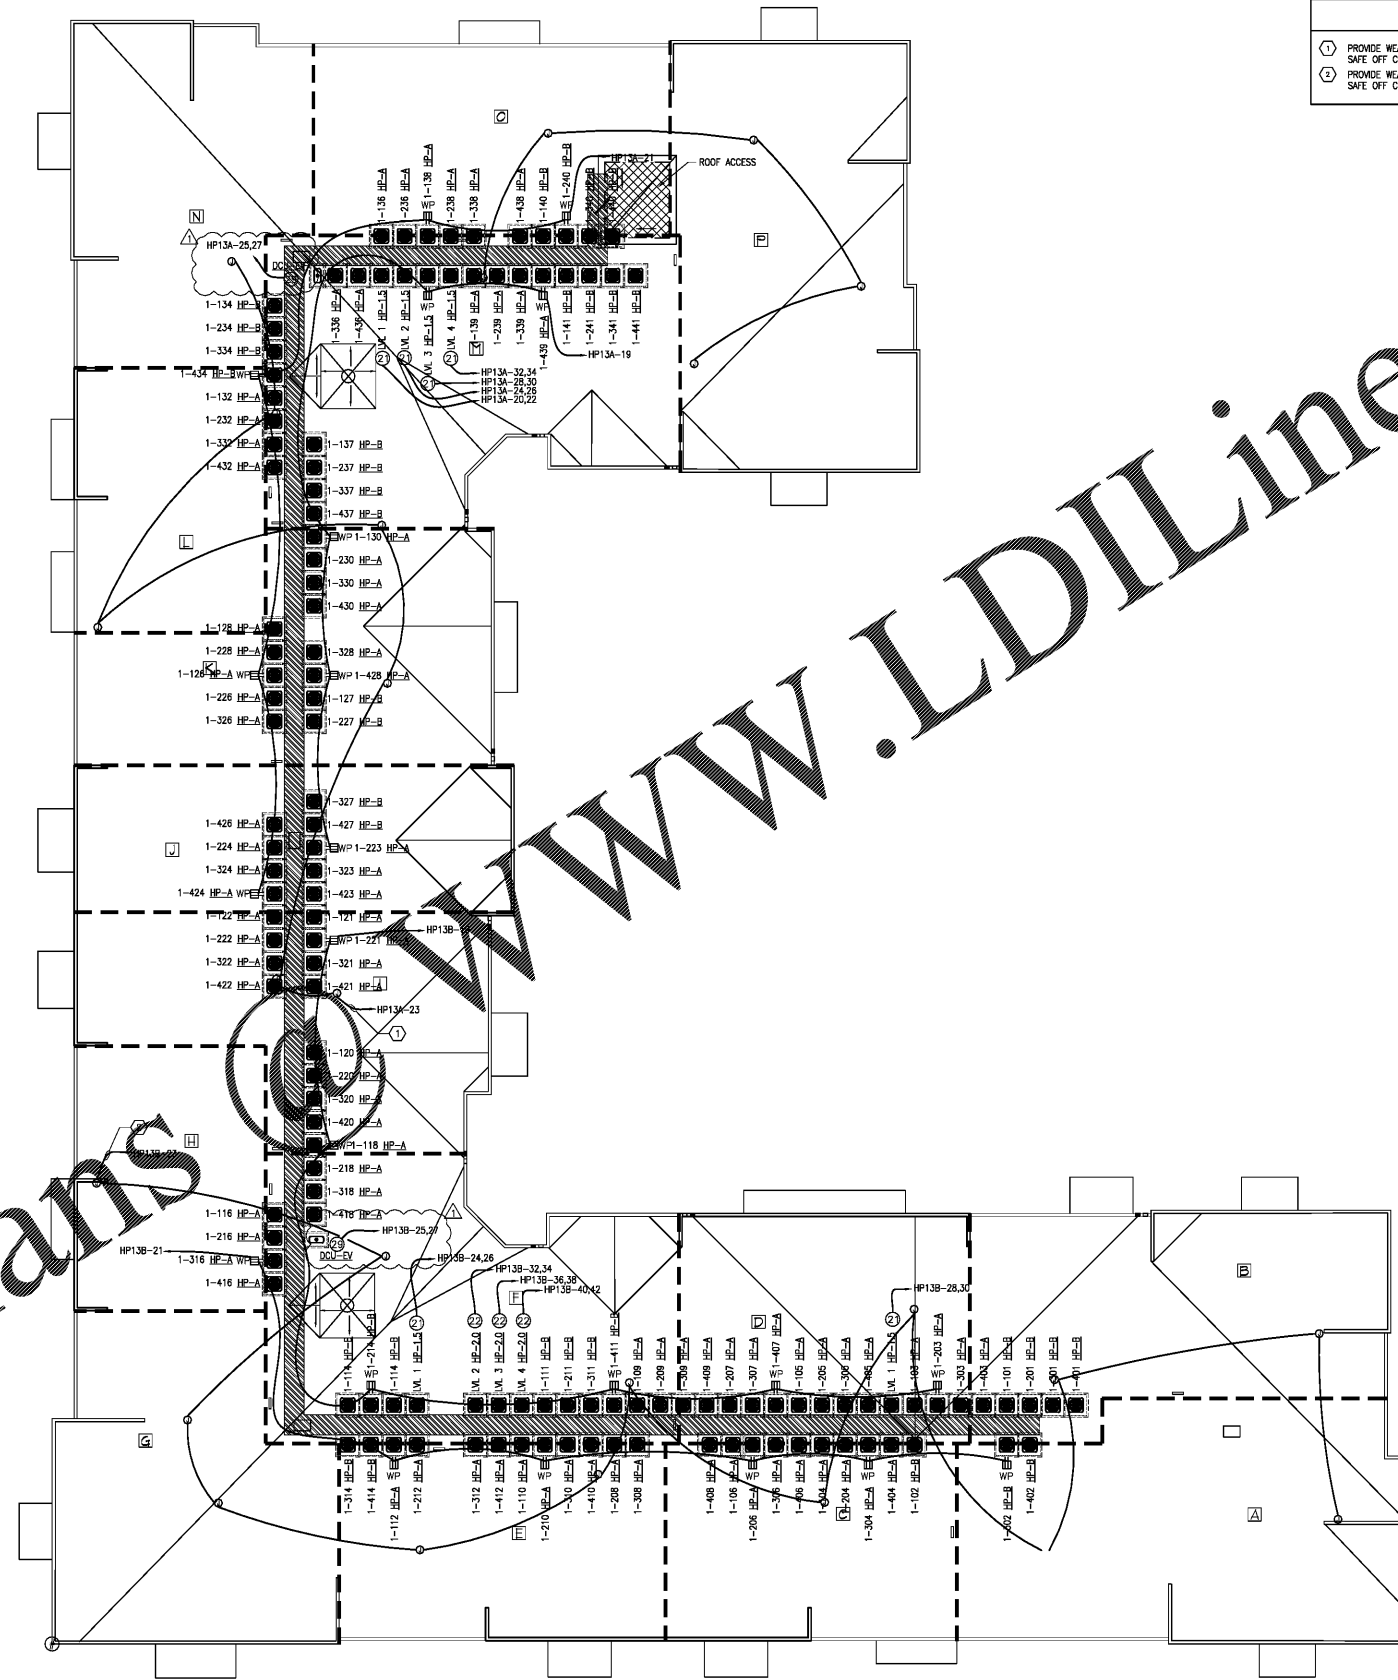

- KEY NOTES**
- 1 PROVIDE WEATHERPROOF JUNCTION BOX FOR FUTURE RADON FAN. CIRCUIT TO HP13A-23 AND SAFE OFF CIRCUIT IN JUNCTION BOX.
 - 2 PROVIDE WEATHERPROOF JUNCTION BOX FOR FUTURE RADON FAN. CIRCUIT TO HP13B-23 AND SAFE OFF CIRCUIT IN JUNCTION BOX.

1 Building 1 - Roof Plan - Electrical
Scale: 3/32" = 1'-0"

Plan



ZPA
POOLE & POOLE ARCHITECTURE
 3736 Winterfield Road, Suite 102
 Midlothian, Virginia 23113
 Telephone 804.275.0215
 www.zpa.net

Project: 1928
 CADD File:
 Drawn By: SW
 Checked By: WM
 Permit Release:
 May 15, 2020
 Construction Release Set:
 May 15, 2020

Revisions

No.	Date	Description
1	03/19/21	Owner Comments


ASI / RFI Revisions

No.	Date	Description
-----	------	-------------

© 2019 Poole & Poole Architecture, LLC
 All drawings and specifications are the property of Poole & Poole Architecture, LLC and shall not be used or reproduced without the written consent of Poole & Poole Architecture, LLC.

POOLE & POOLE ARCHITECTURE, P.C.
 3736 Winterfield Road, Suite 102
 Midlothian, VA 23113
 Telephone: 804.275.0215
 www.zpa.net

Borough 33
 an Apartment Community by
 33 Broad MF, LLC
 in Chattanooga, Tennessee

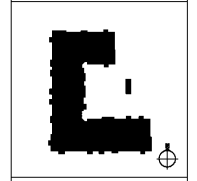

Drawing Title:
 Building 1
 Roof Plan - Electrical

E2.1e

REVISIONS: 03/19/21 (03/19/21)