


Order Plans @ www.LDILine.com

KEY NOTES	
1	PROVIDE WEATHERPROOF JUNCTION BOX FOR FUTURE RADON FAN. CIRCUIT TO HP33-23 AND SAFE OFF CIRCUIT IN JUNCTION BOX.

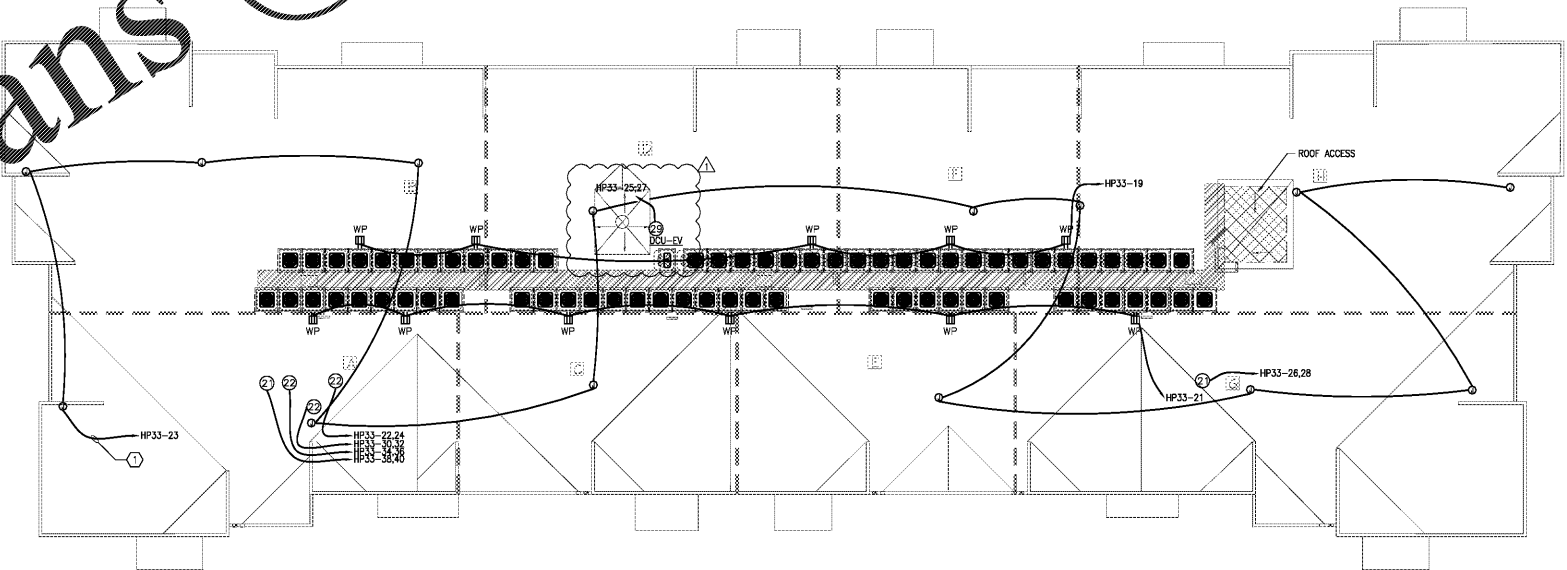

1 Building 3 - Roof Plan - Electrical
Scale: 3/32" = 1'-0"

Plan



ZPA
POOLE & POOLE ARCHITECTURE
3736 Winterfield Road, Suite 102
Midlothian, Virginia 23113
Telephone 804.275.0215
www.zpa.net

Project: 1928
CADD File:
Drawn By: SW
Checked By: WM

Permit Release:
May 15, 2020
Construction Release Set:
May 15, 2020

Revisions
No. Date Description

ASI / RFI Revisions
No. Date Description

© 2019 Poole & Poole Architecture, LLC
Design and specifications are the property of Poole & Poole Architecture, LLC and shall not be used or reproduced in whole or part in any form without the written consent of Poole & Poole Architecture, LLC.



Borough 33
an Apartment Community by
33 Broad MF, LLC
in Chattanooga, Tennessee



Drawing Title:
Building 3
Roof Plan - Electrical

E2.3c

REVISIONS: 05/14/2020