


Order Plans @ [www.LDILine.com](http://www.LDILine.com)

- GENERAL NOTES** (THIS SHEET ONLY)
- INDICATES HVAC EQUIPMENT. SEE E8-01 FOR MECHANICAL EQUIPMENT CONNECTION SCHEDULE.
  - DO NOT INSTALL DEVICES BACK TO BACK IN ANY FIRE RATED WALL. PROVIDE MINIMUM 24" HORIZONTAL SPACE BETWEEN SUCH OUTLETS.
  - SEAL ALL PENETRATIONS IN EVERY FIRE RATED WALL AND FLOOR PER UL TO MAINTAIN THE WALL AND FLOOR ORIGINAL RATING.
  - FINAL LIGHTING LOCATIONS AND SELECTIONS TO BE DETERMINED BY ARCHITECT/INTERIOR DESIGNER.
  - PROVIDE #10 CONDUCTORS FOR ANY 120V CIRCUIT OVER 100'. PROVIDE #8 CONDUCTOR FOR ANY CIRCUIT OVER 150'.
  - PROVIDE CONNECTION TO FIRE ALARM CONTROL PANEL FROM ALL FIRE ALARM DEVICES.
  - TYPE NLM WIRING FOR BRANCH CIRCUIT WIRING FOR TYPE III, IV AND V CONSTRUCTION IF ACCEPTABLE TO LOCAL AUTHORITY HAVING JURISDICTION. PROVIDE N.E.C. CABLE OR WIRE/EXIT CONDUIT FOR BRANCH CIRCUITS IN ALL OTHER CONSTRUCTION TYPES AND IN RETURN AIR PLenums ROOMS OR SPACES.
  - COORDINATE LOCATION AND QUANTITY OF FIRE/SMOKE AND/OR SMOKE DAMPERS WITH MECHANICAL CONTRACTOR PRIOR TO BID. COORDINATION OF LOCATIONS AND QUANTITIES WILL OVERRIDE LOCATIONS AND QUANTITIES INDICATED ON ELECTRICAL DRAWINGS. PROVIDE A 120V UNSWITCHED CIRCUIT TO EACH FIRE/SMOKE DAMPER AND/OR SMOKE DAMPER. PROVIDE A DUCT MOUNTED SMOKE DETECTOR IN FIRE/SMOKE DAMPER SHAFT. CONNECT DUCT MOUNTED SMOKE DETECTOR AND FIRE/SMOKE AND/OR SMOKE DAMPER TO FIRE ALARM SYSTEM. A CHANGE ORDER WILL NOT BE ALLOWED FOR LACK OF COORDINATION BETWEEN THE ELECTRICAL AND MECHANICAL CONTRACTOR FOR LOCATION AND QUANTITY OF FIRE/SMOKE DAMPER AND/OR SMOKE DAMPERS.
  - ALL CEILING MOUNTED CORRIDOR LIGHTING FIXTURES ARE TYPE 'X'.
  - ALL UNIT ENTRY WALL SOUNDC LIGHTING FIXTURES ARE TYPE 'B'.
  - ALL STRIP FIXTURES ARE TYPE '12/CE'.
  - ALL STAIRWELL FIXTURES ARE TYPE 'DE'.
  - ALL EMERGENCY LIGHTING FIXTURES ARE TYPE 'EM'.
  - ALL EXIT SIGNS ARE TYPE 'EX'.

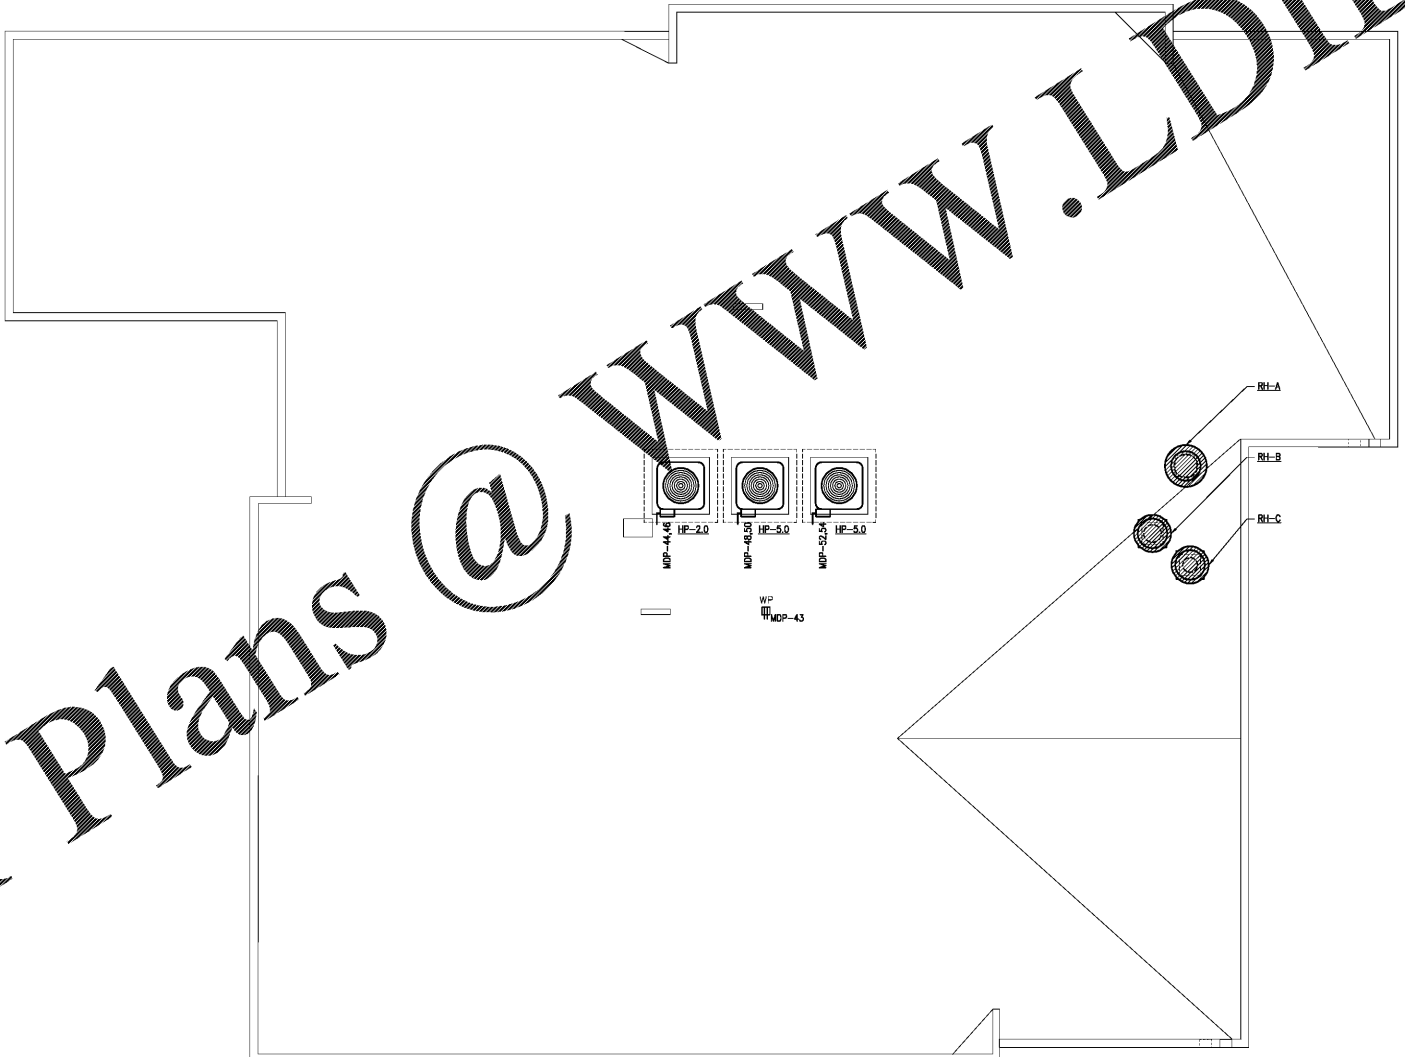

1 Fitness Roof Plan - Electrical  
Scale: 1/4" = 1'-0"

Seal

5-14-2020

**ZPA**  
**POOLE & POOLE ARCHITECTURE**  
3736 Winterfield Road, Suite 102  
Midlothian, Virginia 23113  
Telephone 804.275.0215  
www.zpa.net

Project: 1928  
CADD File:  
Drawn By: SW  
Checked By: WM

Permit Release:  
May 19, 2020  
Construction Release Set:  
May 19, 2020

Revisions

No.	Date	Description

ASI / RFI Revisions

No.	Date	Description

© 2019 Poole & Poole Architecture, LLC. Design and architectural drawings and documents are the property of Poole & Poole Architecture, LLC and shall not be used, reproduced, or transmitted in any form or by any means without the written consent of Poole & Poole Architecture, LLC.

**PRISONS GRAFIX ENGINEERING, F.C.** REGISTERED PROFESSIONAL ENGINEER  
1000 W. 10th Street, Suite 200, Oklahoma City, Oklahoma 73106  
Tel: 405.521.1111 Fax: 405.521.1112  
This drawing is an unrecorded plan and shall remain the property of Poole & Poole Architecture, LLC and shall not be used, reproduced, or transmitted in any form or by any means without the written consent of Poole & Poole Architecture, LLC. The reproduction or use of this drawing without the written consent of Poole & Poole Architecture, LLC is prohibited.

**Borough 33**  
an Apartment Community by  
33 Broad MF, LLC  
in Chattanooga, Tennessee

Drawing Title:  
Fitness Roof Plan - Electrical

**E6.6**

REVISIONS: 04/27/2020 (E6.6)