


Order Plans @ www.LDILine.com

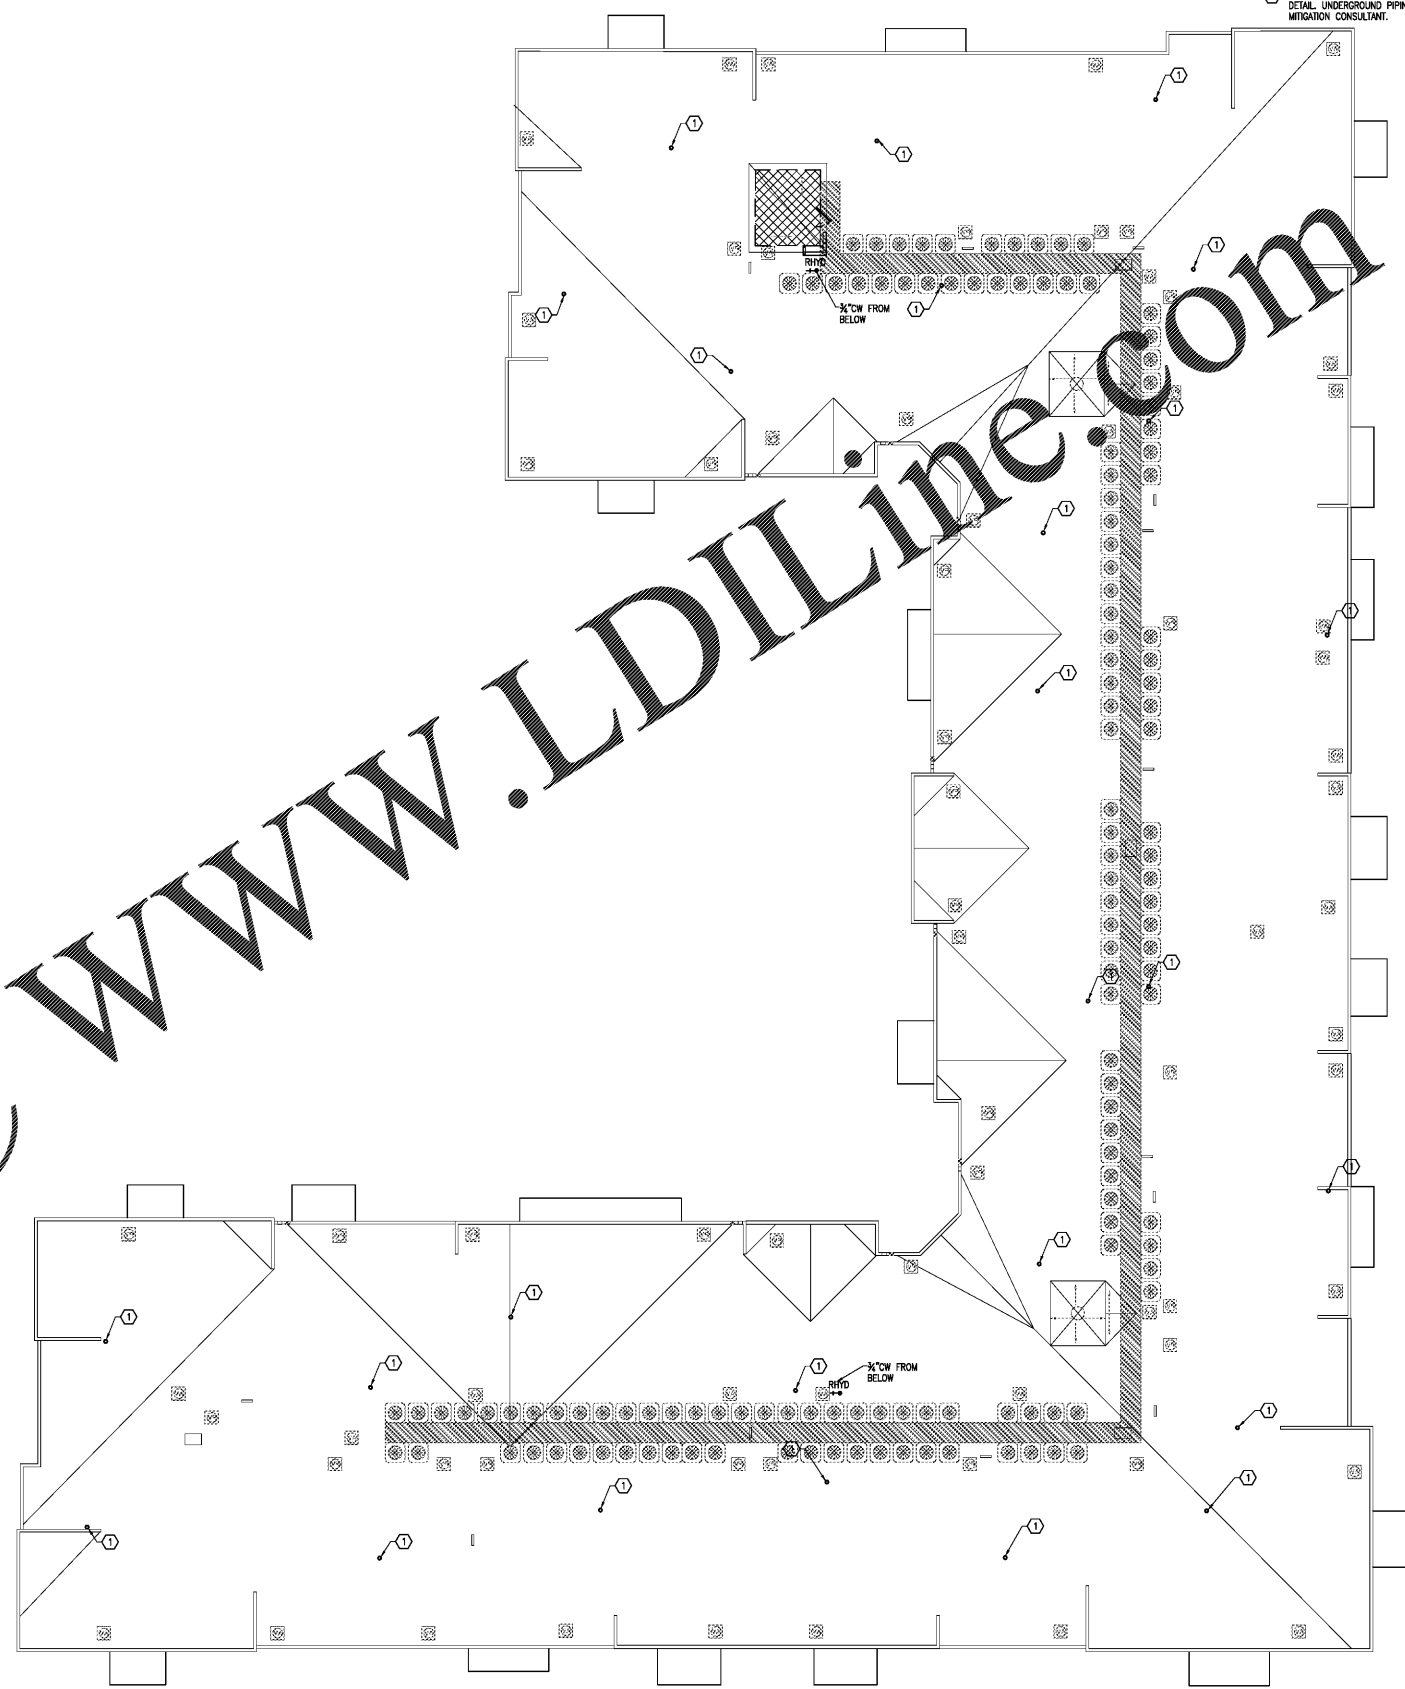

NOTES:
1. SEE POLX SERIES FOR GENERAL NOTES, SCHEDULES AND DETAILS.
2. ROOF DRAINAGE BY SCUPPERS AND DOWNSPOUTS PROVIDED BY OTHERS. SEE ARCHITECTURAL AND CIVIL DRAWINGS FOR DETAILS.
3. VAPOR VENT. SEE POLJ FOR PIPING DETAIL. UNDERGROUND PIPING BY VAPOR MITIGATION CONSULTANT.

Seal



5-14-2020

ZPA

POOLE & POOLE ARCHITECTURE
3736 Winterfield Road, Suite 102
Midlothian, Virginia 23113
Telephone 804.275.0215
www.zpa.net

Project: 1928
CADD File:
Drawn By: BC
Checked By: CB

Permit Release:
May 15, 2020
Construction Release Set:
May 15, 2020

Revisions

No.	Date	Description

ASI / RFI Revisions

No.	Date	Description

© 2019 Poole & Poole Architecture, LLC
Drawings and specifications are the intellectual property of Poole & Poole Architecture, LLC and shall not be used for any other project or purpose without the written consent of Poole & Poole Architecture, LLC.

PRINCE GRADEK ENGINEERING, P.C.
1116 W. Brentwood Drive
Brentwood, TN 37027
615-875-1116

Princkle is an equal opportunity employer. All qualified applicants will receive consideration for employment without regard to race, color, religion, sex, national origin, age, or disability. This document contains confidential information. If you have received this document in error, please notify the sender immediately. Thank you for your attention to this matter.

Borough 33
an Apartment Community by
33 Broad MF, LLC
in Chattanooga, Tennessee



Drawing Title:
Building 2
Roof Plan

P2.2e

1 Building 2 - Roof Plan
Scale: 3/32" = 1'-0"

Plan

REVIEW FOR PERMIT (P/MP)